

PULL STATION

FIRE EXTINGUISHER



EXIT

FIRE HOSE CABINET


MATSQUI RECREATION CENTRE

3106 CLEARBROOK ROAD

ABBOTSFORD, B.C.

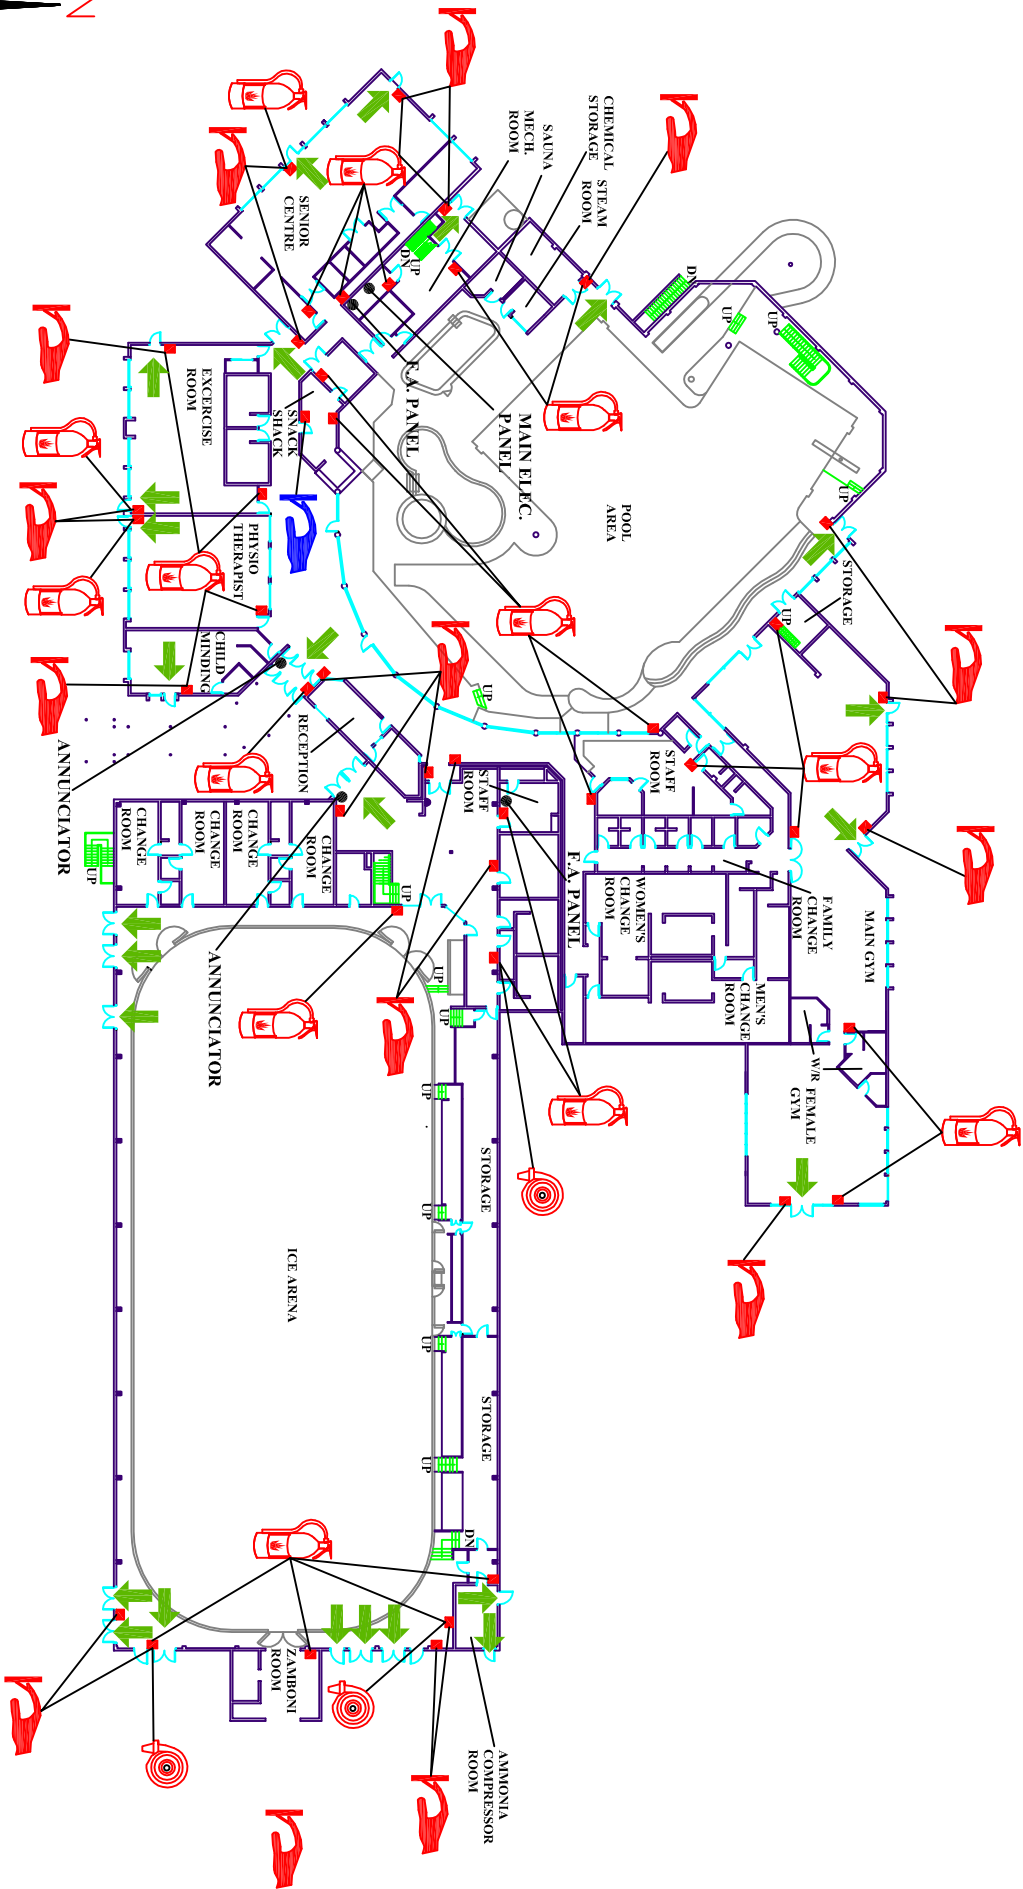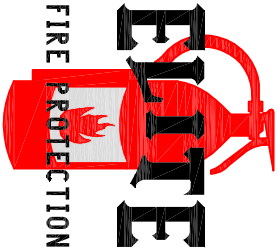

MAIN FLOOR PLAN

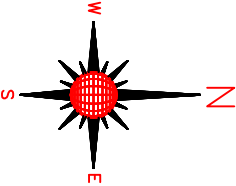

DATE:

SEPTEMBER 2005

FILE NAME:

0135-B1B

DRAWN BY:

Elite Fire Protection