

M.S.A. ARENA



2323 EMERSON ROAD

ABBOTSFORD, B.C.



PULL STATION
 FIRE EXTINGUISHER
 EXIT
 KITCHEN PULL STATION
 WATER SHUT-OFF
 ELECTRICAL SHUT-OFF
 F/A ANNUNCIATOR PANEL
 CENTRAL CONTROL PANEL

LEGEND

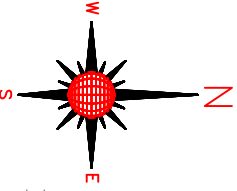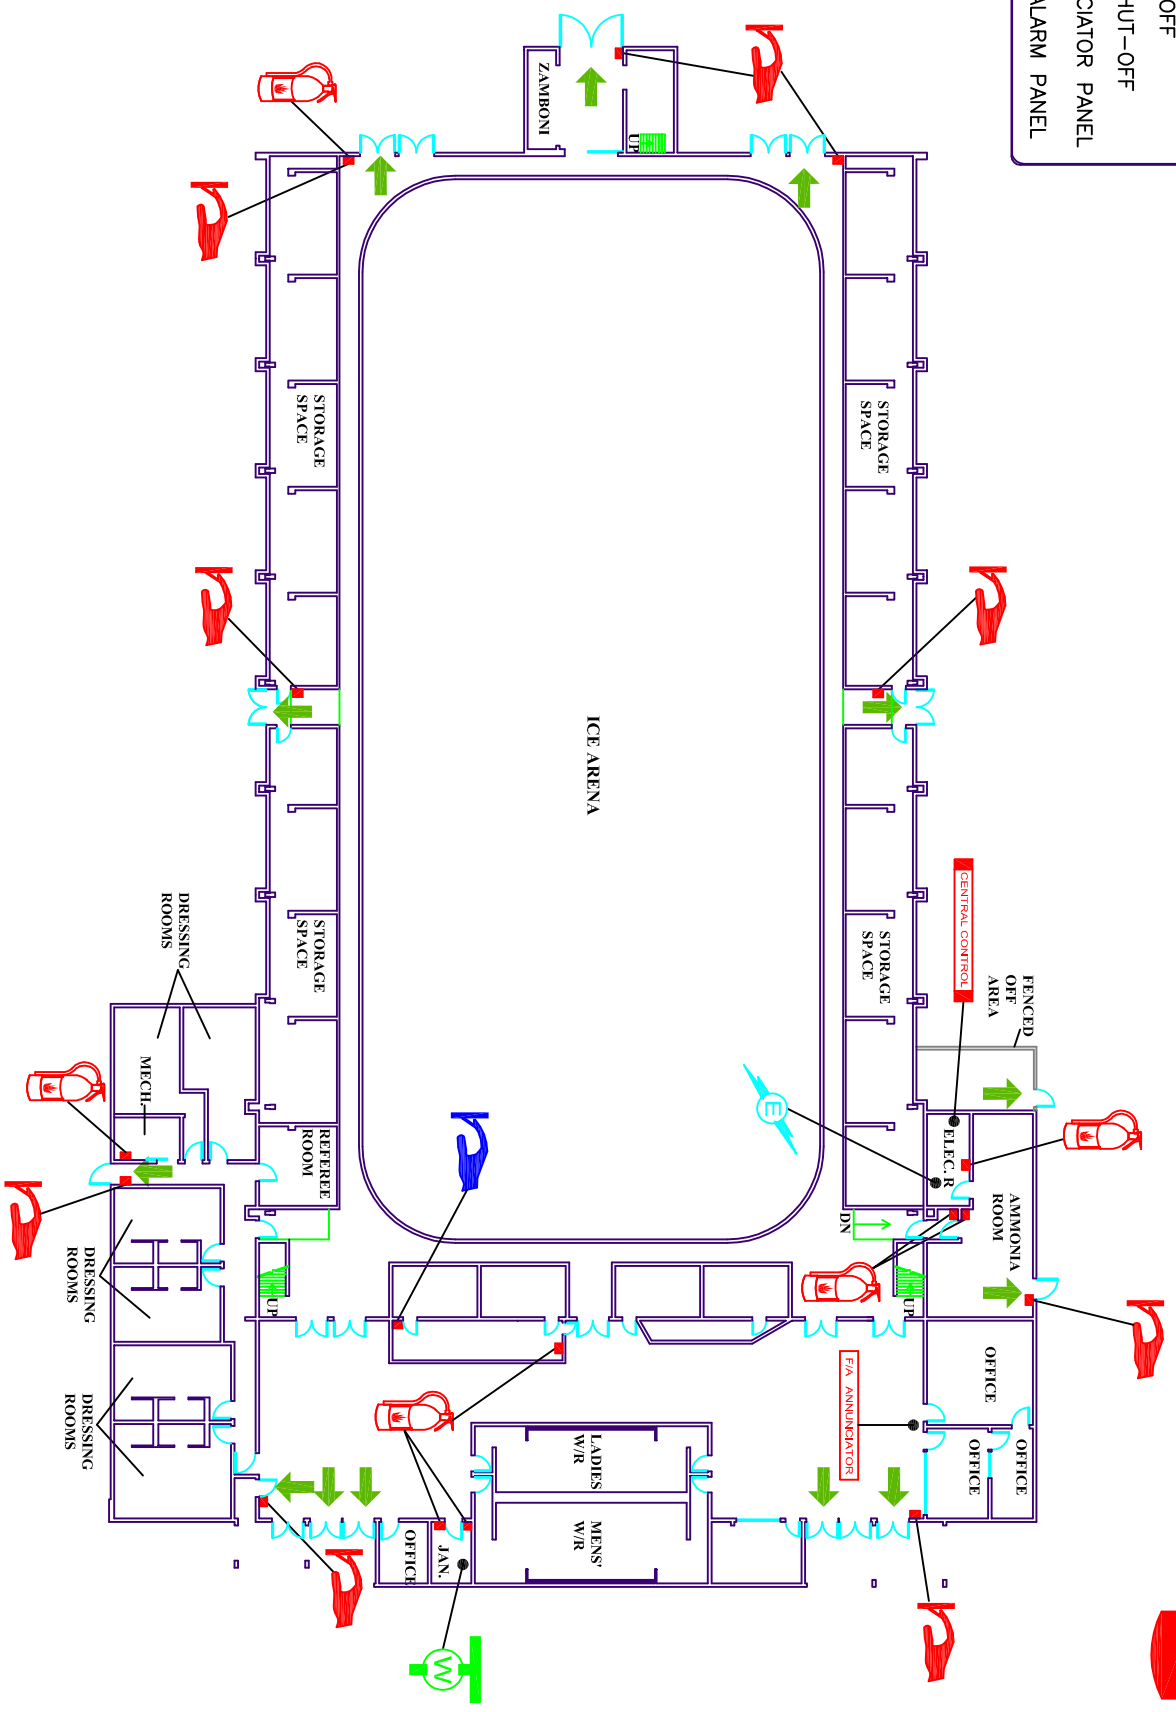

MAIN FLOOR PLAN

DATE: NOVEMBER 2005

FILE NAME: 0148-B1A

DRAWN BY: Elite Fire Protection